


10TH ST. & CR 200 E. WATER MAIN EXTENSION

SEC. 01-02, 06, T15N, R1W, HENDRICKS COUNTY, CENTER TOWNSHIP, DANVILLE, INDIANA

22158 10TH ST. & CR 200 E. WATER MAIN EXTENSION


PROJECT LOCATION

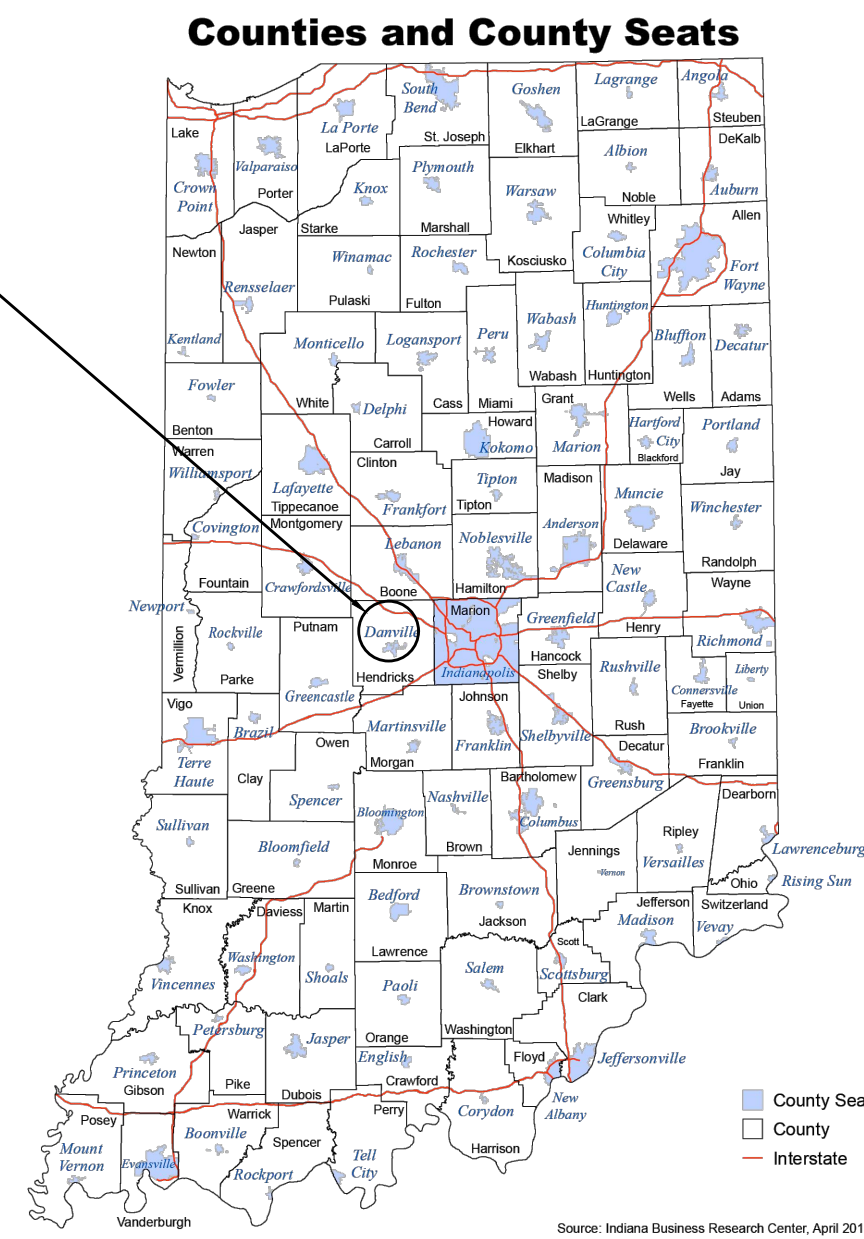


VICINITY MAP
NO SCALE

PLANS PREPARED FOR:
TOWN OF DANVILLE
49 NORTH WAYNE STREET
DANVILLE, IN 46122
PHONE: 317-745-4180
FAX: 317-745-3002
CONTACT: BARRY LOFTON
EMAIL: blofton@danvillein.gov

PROJECT LOCATION

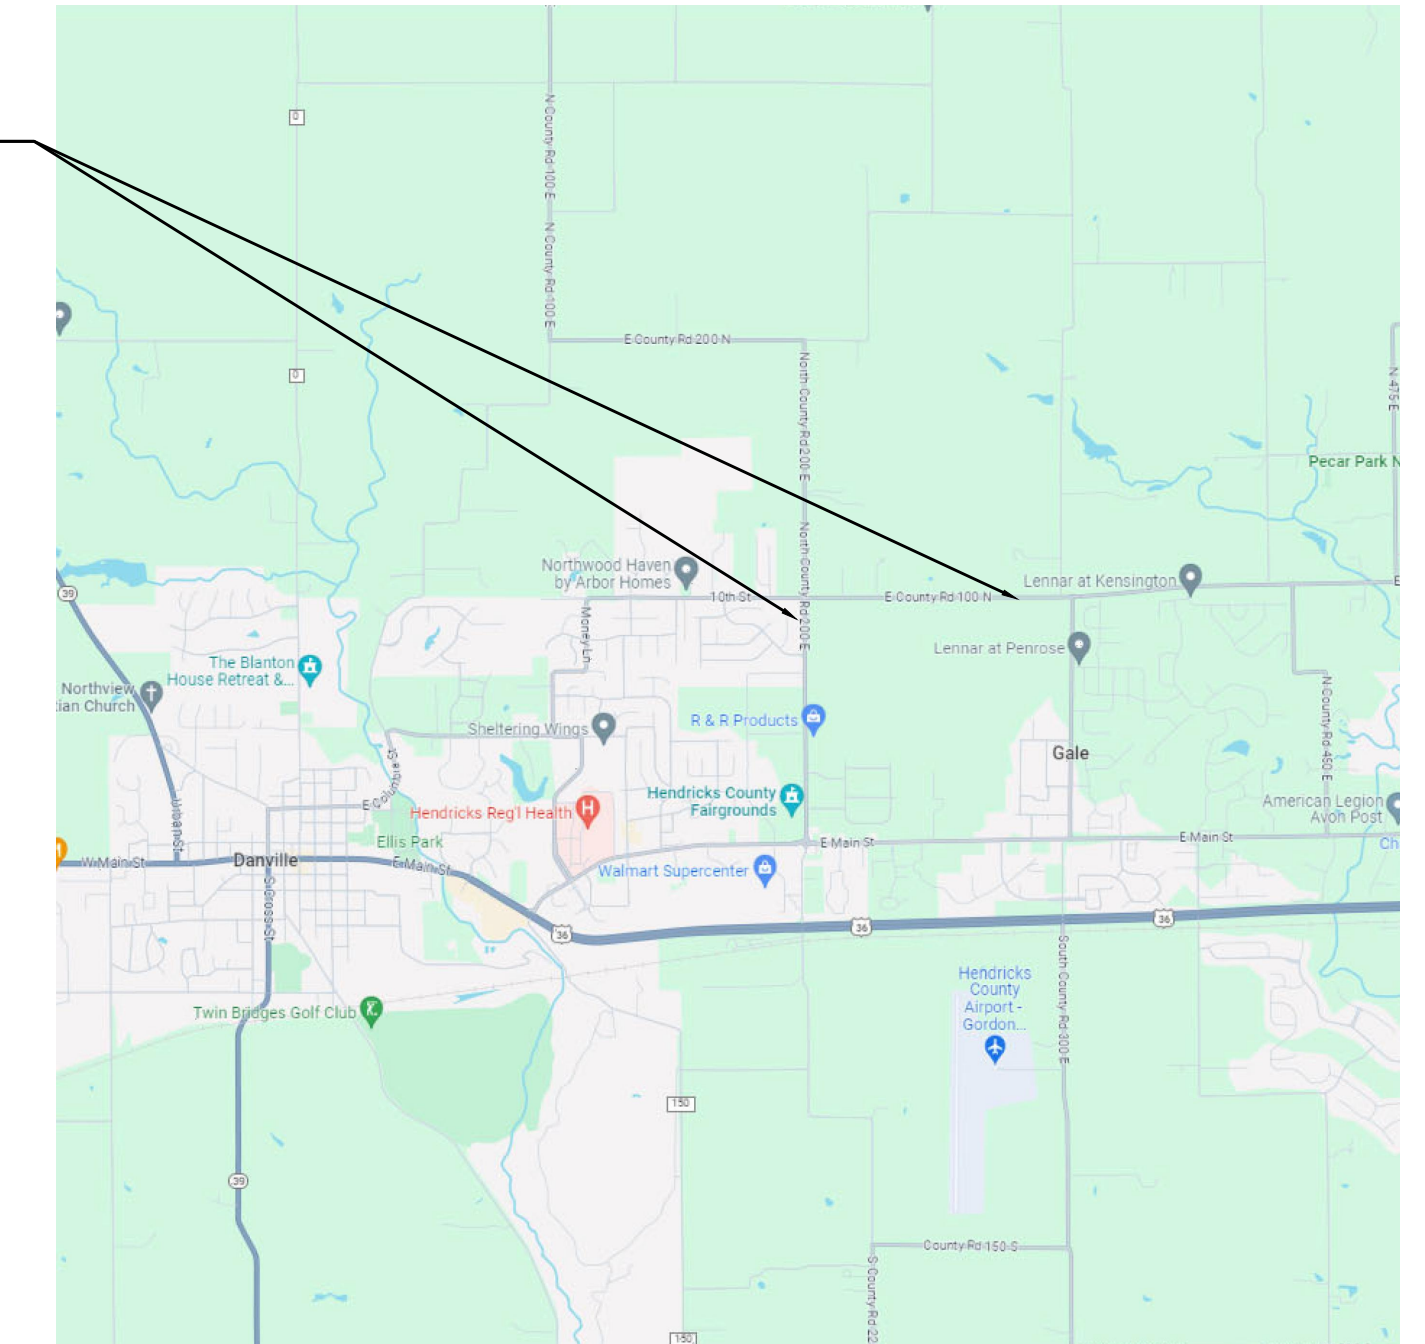

LOCATION MAP
NO SCALE

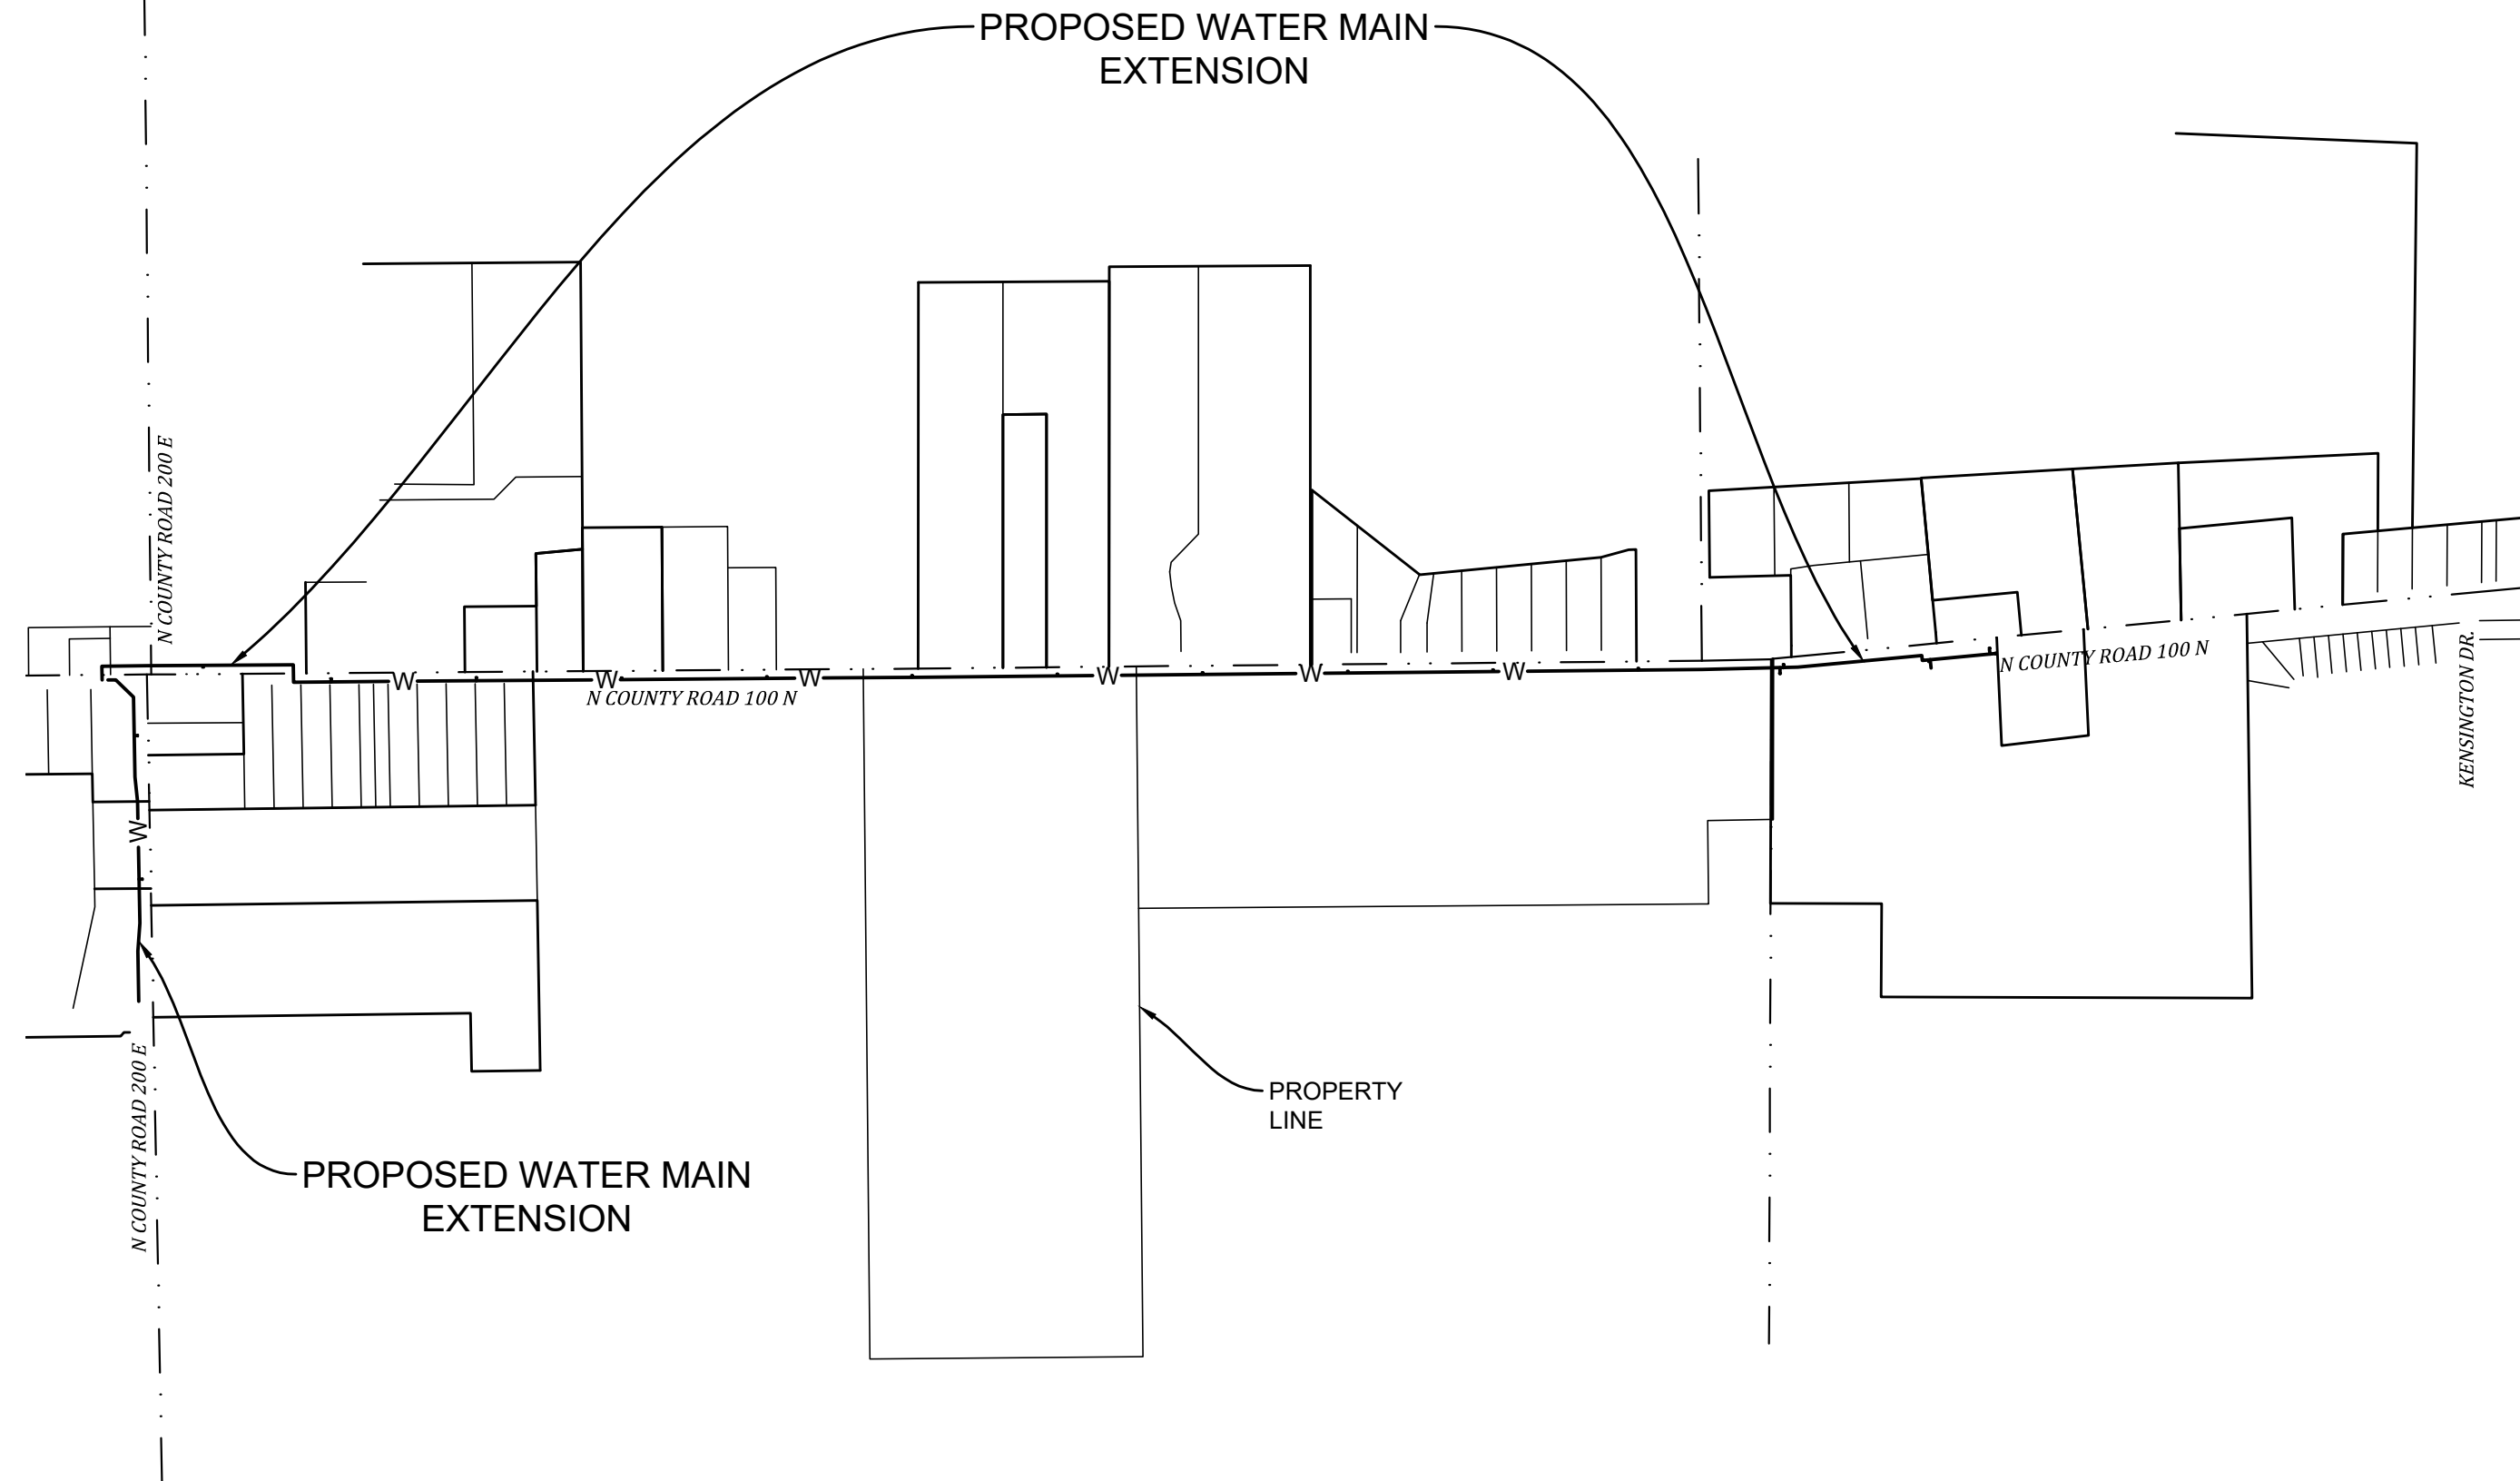

SITE MAP
NO SCALE

OPERATING AUTHORITIES

- | | | |
|--|--|--|
| GAS
Vectren
1800 W. 26th St.
Muncie, IN 47302
765-287-2119 | TELEPHONE
AT&T
240 N. Meridian St.
Indianapolis, IN 46204
317-265-3050
Matt Spindler | ELECTRIC
Duke Energy
390 N. Main St.
Martinsville, IN 46151
765-349-4012
Tim Umbaugh |
| ELECTRIC
Hendricks Power Cooperative
86 N. 500 E.
Avon, IN 46123
317-745-5473
Jason Stewart | CABLE TELEVISION
Comcast
6330 E. 65th Street
Indianapolis, IN 46220
317-872-2225 | COMMUNICATION
Endeavor Communications
2 S. West St.
Cloverdale, IN 46120
800-922-6677 |
| SANITARY
Danville Sanitary Dept.
1000 E. Broadway Street
Danville, IN 46122
317-745-4180 Ex. 2002 | STORM
Danville Stormwater Dept.
49 N. Wayne Street
Danville, IN 46122
317-745-4180 Ex. 3001 | WATER
Danville Water Department
620 E. Main Street
Danville, IN 46122
317-745-4180 Ex. 8002 |
| SCHOOL DISTRICT
Danville Community School Corp.
200 Warrior Way
Danville, IN 46122
317-745-2212 | FIRE DEPARTMENT
Danville Fire Department
77 N. Kentucky Street
Danville, IN 46122
317-745-4180 Ex. 9001 | |

BOARD MEMBERS

- DAVID POTTER, PRESIDENT
MICHAEL CHATHAM, VICE PRESIDENT
GREG IRBY, MEMBER
BRET DOUB, MEMBER
CHRIS GERALD, MEMBER

UTILITY ADMINISTRATORS

- MARK MORGAN, TOWN MANAGER
BARRY LOFTON, UTILITIES DIRECTOR
MATT ELLISON, WATER SUPERINTENDENT

REVISIONS

NUMBER	DESCRIPTION	DATE
1	UPDATED HYDRANTS FROM 25+20 TO 66+90	01-23-25
1	ADDED SECOND VALVE AT EACH HYDRANT	01-23-25

SHEET INDEX

SHEET NO	DESCRIPTION
C100	TITLE SHEET
C101	OVERALL PLAN
C300-C307	10TH ST. WATER MAIN PLAN AND PROFILE
C308-C309	CR 200 E WATER MAIN PLAN AND PROFILE
C400-C405	EROSION CONTROL PLAN
C407	STORM WATER POLLUTION PREVENTION PLAN
C500-C501	WATER MAIN DETAILS
C502	MISCELLANEOUS DETAILS
15-17	TOWN OF DANVILLE EROSION CONTROL STANDARDS

PLANS PREPARED BY:

BANNING ENGINEERING
853 COLUMBIA ROAD, SUITE #101
PLAINFIELD, IN 46168
BUS: (317) 707-3700, FAX: (317) 707-3800
E-MAIL: Banning@BanningEngineering.com
WEB: www.BanningEngineering.com
CONTACT: JOSH SELIG
EMAIL: jselig@banning-eng.com

CONSTRUCTION DOCUMENTS

PROJECT MANAGER: *J. Selig* DATE: 02-18-25
THESE PLANS ARE NOT TO BE CONSIDERED FINAL OR TO BE UTILIZED FOR CONSTRUCTION UNLESS SIGNED AND DATED BY THE APPROPRIATE BANNING ENGINEERING PROJECT MANAGER.
THESE PLANS ARE NOT INTENDED TO BE REPRESENTED AS A RETRACEMENT OR ORIGINAL BOUNDARY SURVEY, A ROUTE SURVEY, OR A SURVEYOR LOCATION REPORT.



CERTIFIED BY: *J. Selig*

Date: 02-18-25
Project No: 22158
Sheet No:

C100

